


LEGEND : DRAWING SYMBOLS (CONT'D)		
SYMBOL	DESCRIPTION	
	CEILING MOUNTED SPEAKER	REFER TO CONSULTANT'S DRAWINGS FOR SPECIFICATIONS & LOCATIONS
	WALL MOUNTED EXIT LIGHT	REFER TO CONSULTANT'S DRAWINGS FOR SPECIFICATIONS & LOCATIONS
	CEILING MOUNTED EXIT LIGHT	REFER TO CONSULTANT'S DRAWINGS FOR SPECIFICATIONS & LOCATIONS
	CEILING MOUNTED OCCUPANCY SENSOR	REFER TO CONSULTANT'S DRAWINGS FOR SPECIFICATIONS & LOCATIONS
	CEILING OR WALL MOUNTED SMOKE DETECTOR	REFER TO CONSULTANT'S DRAWINGS FOR SPECIFICATIONS & LOCATIONS

LEGEND : WALL SCONCE & PENDANT MOUNTING HEIGHTS	
NOTE: ALL PENDANT DIMENSIONS ARE FROM UNDERSIDE OF FIXTURE TO FINISHED FLOOR. ALL WALL SCONCE DIMENSIONS ARE FROM CENTRE OF FIXTURE TO FINISHED FLOOR	
 L.9	2150MM
 L.28	2750MM


6. MECHANICAL AND ELECTRICAL WORK TO COMPLY WITH THE REQUIREMENTS OF THE BUILDING DEPARTMENT AND AUTHORITIES. HAVE JURISDICTION.
7. TO PROVIDE DESIGNER DRAWINGS FOR LOCATION OF CEILING FIXTURES. REFER TO MECHANICAL DRAWINGS FOR SPECIFICATIONS.
8. CONTRACTOR TO CROSS REFERENCE BETWEEN DESIGNER'S ELECTRICAL DRAWINGS, DESIGNER'S MECHANICAL DRAWINGS AND SITE CONDITIONS. REFLECT DISCREPANCIES TO DESIGNER TO CORRECT.
9. CONTRACTOR TO PROVIDE PIPING IN DRYWALL CEILING TO ACCOMMODATE SPRINKLERS, EXIST LIGHTS, ACCESS PASSES, RECESSED DOWN LIGHTS, AIR DIFFUSERS, ETC. DESIGNER TO SUPPLY SCHEDULE.
10. CONTRACTOR TO PROVIDE DETAILLED CEILING, TRIM AND ENGINEERING DRAWINGS AND SPECIFICATIONS.
11. LIGHT FIXTURES AND SWITCHES TO BE LOCATED IN ACCORDANCE WITH DESIGNER'S ELECTRICAL DRAWINGS. PROVIDE ACCESSORIES AND SUPPLIES FOR INSTALLATION.
12. CONTRACTOR TO PROVIDER AIR TRANSFER DUCTS IN ACCORDANCE WITH MECHANICAL DRAWINGS WHERE CONSTRUCTION OCCURS ABOVE SUSPENDED CEILING TO U/S OF SUEB.
13. TO PROVIDE ELECTRICAL SUPPLIES AND ACCESSORIES.
14. TO PROVIDE ELECTRICAL CONNECTIONS TO ALL ELECTRICAL EQUIPMENT.
15. TO PROVIDE ELECTRICAL CONNECTIONS TO ALL ELECTRICAL EQUIPMENT.
16. TO PROVIDE ELECTRICAL CONNECTIONS TO ALL ELECTRICAL EQUIPMENT.
100. TO PROVIDE ELECTRICAL CONNECTIONS TO ALL ELECTRICAL EQUIPMENT.

Notes:

1. CONTRACTOR AND ALL SUB-TRADES SHALL VERIFY ALL SITE DIMENSIONS, ALL DRAWINGS, DETAILS AND SPECIFICATIONS AND REPORT ANY DISCREPANCIES TO THE INTERIOR DESIGNER BEFORE WRITING FOR APPROVAL BEFORE PROCEEDING WITH THE WORK.
2. CONTRACTOR AND SUB-CONTRACTORS, BEFORE PROCEEDING WITH WORK, MUST SUBMIT ALL NECESSARY DOCUMENTS FOR APPROVAL OF QUALITY AND FINISH TO THE INTERIOR DESIGNER.
3. CONTRACTOR MUST COMPLY WITH THE CONTRACT DOCUMENTS, PERFORMANCE REQUIREMENTS, APPLICABLE CODES AND REGULATIONS.
4. ALL DRAWINGS AND WRITTEN MATERIAL HEREIN SHALL BE THE PROPERTY OF THE INTERIOR DESIGNER. NO PART OF THE WORK OF "IBBY IV DESIGN ASSOCIATES INC.", AND MAY NOT BE DUPLICATED, USED OR DISCLOSED WITHOUT PRIOR WRITTEN PERMISSION OF "IBBY IV DESIGN ASSOCIATES INC."
5. DRAWINGS NOT TO BE SCALED

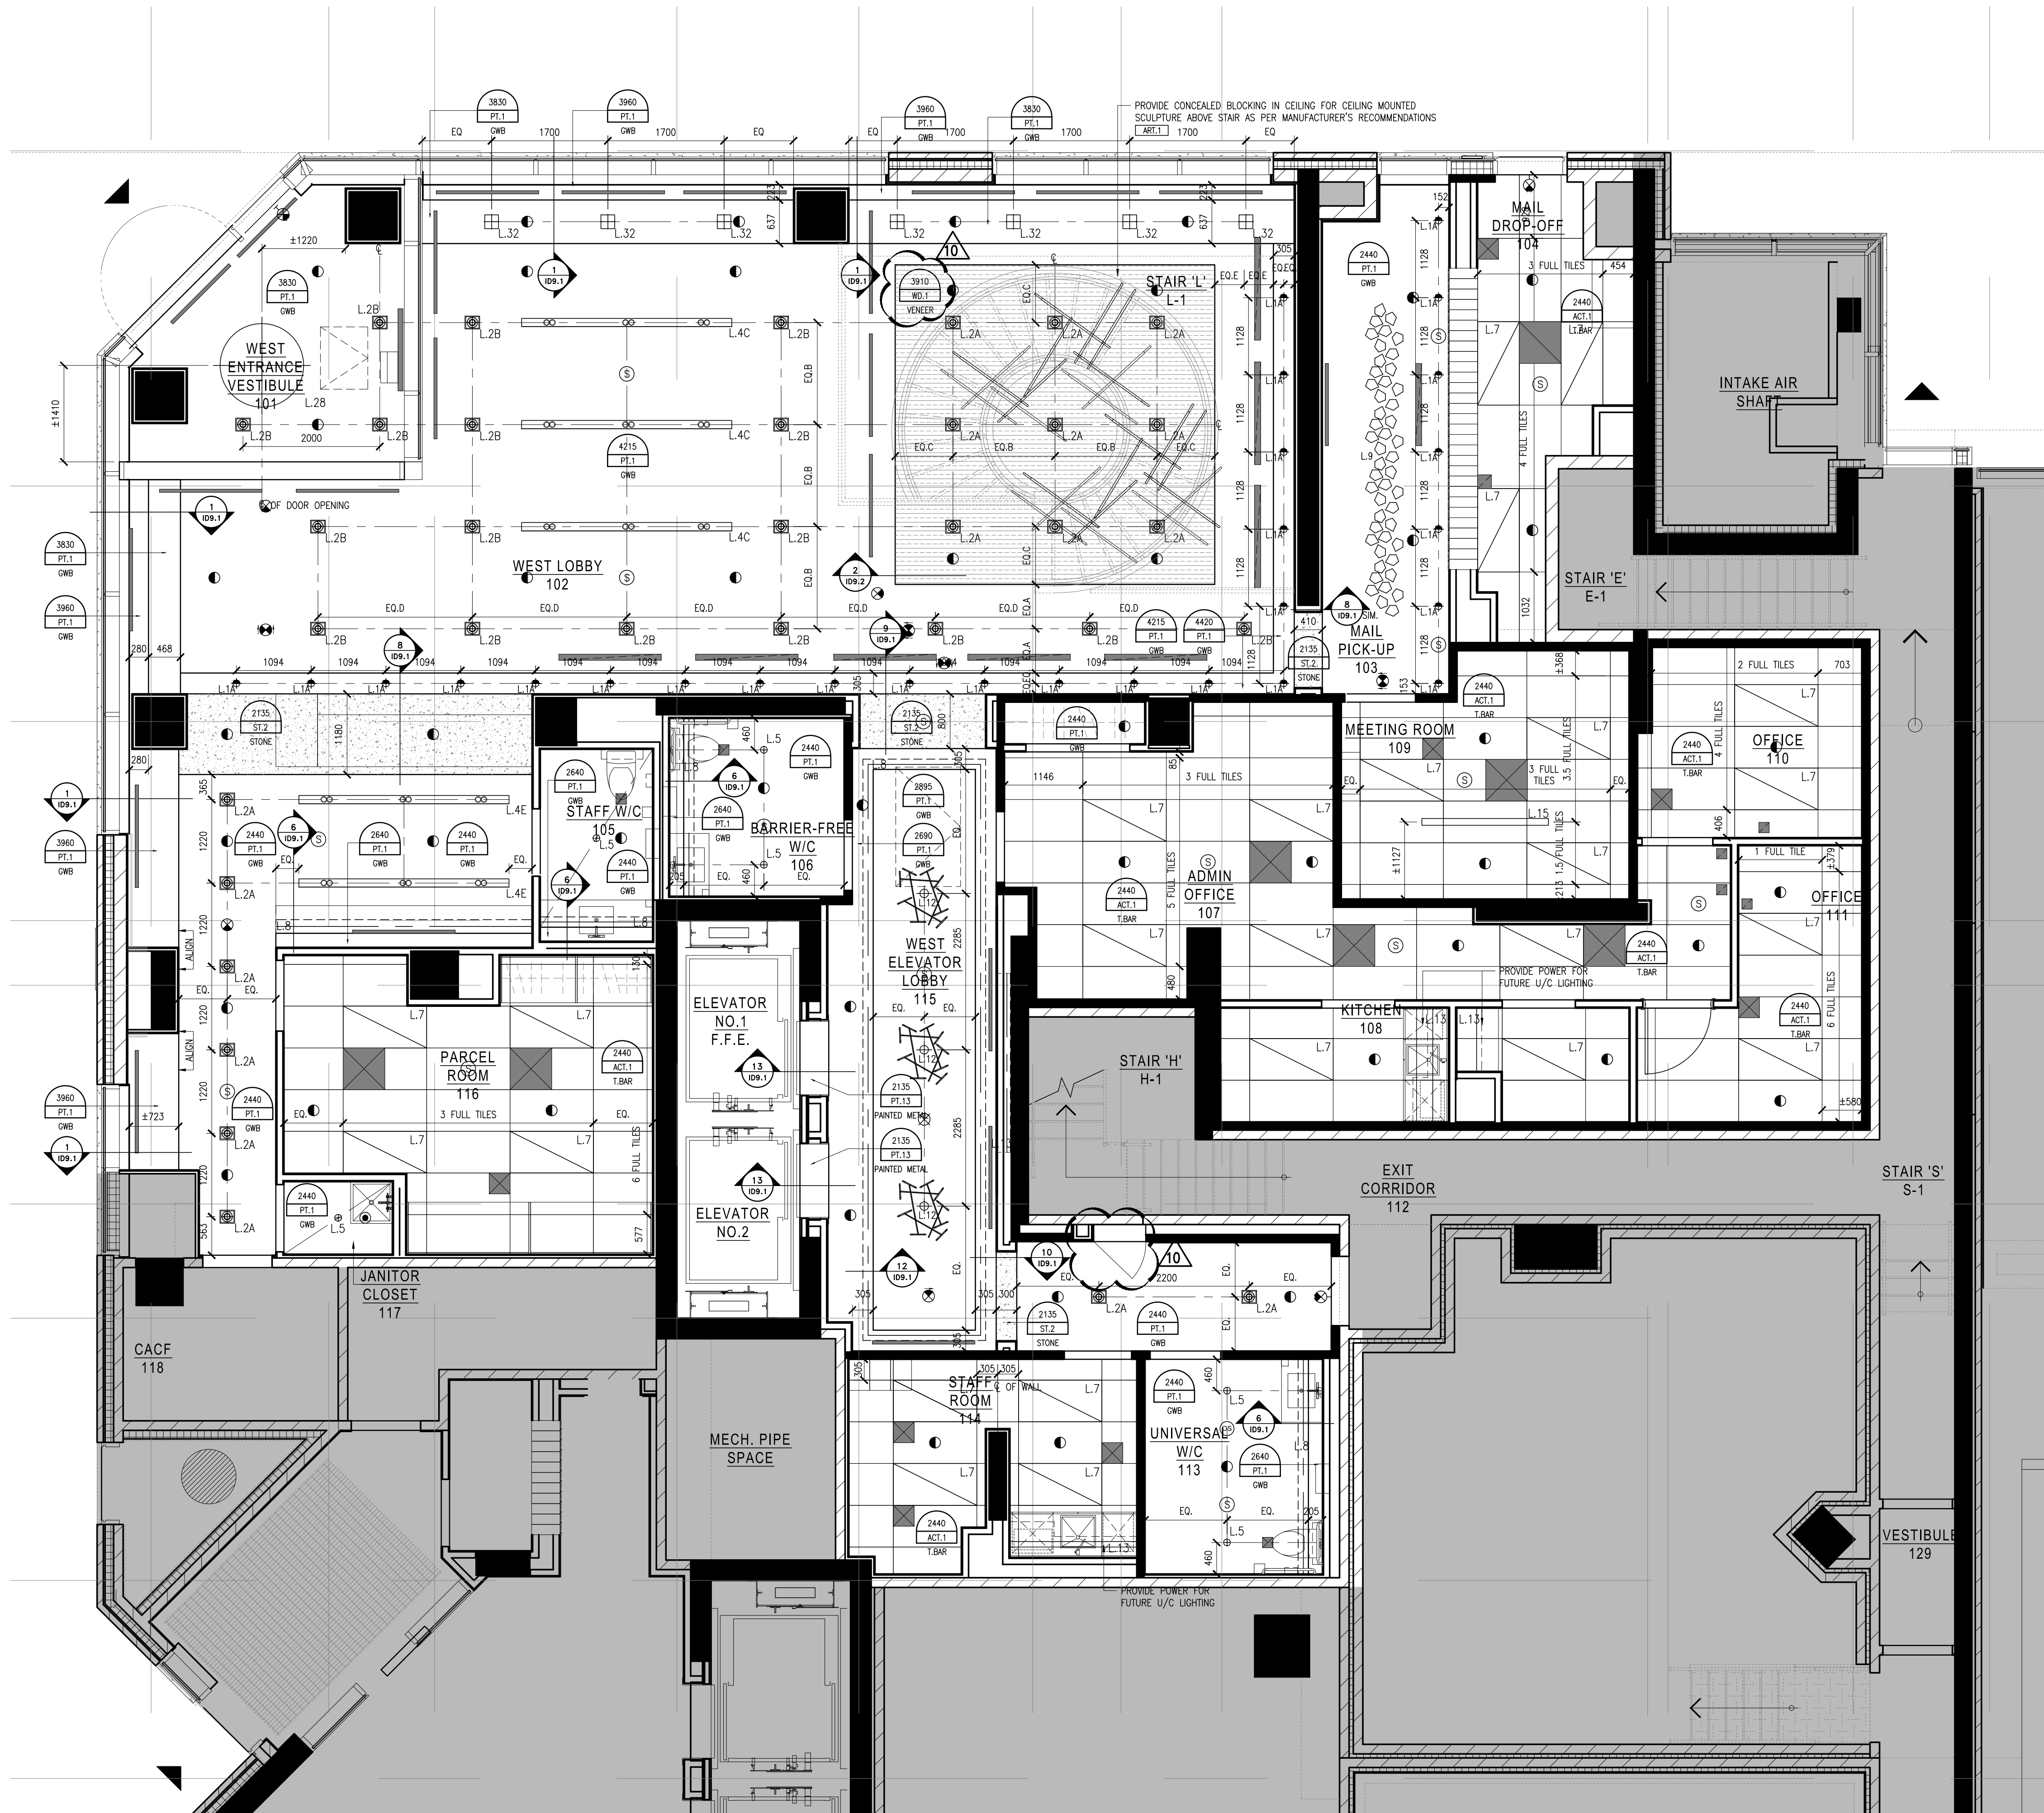

1 REFLECTED CEILING PLAN
103.6 SCALE 1:50

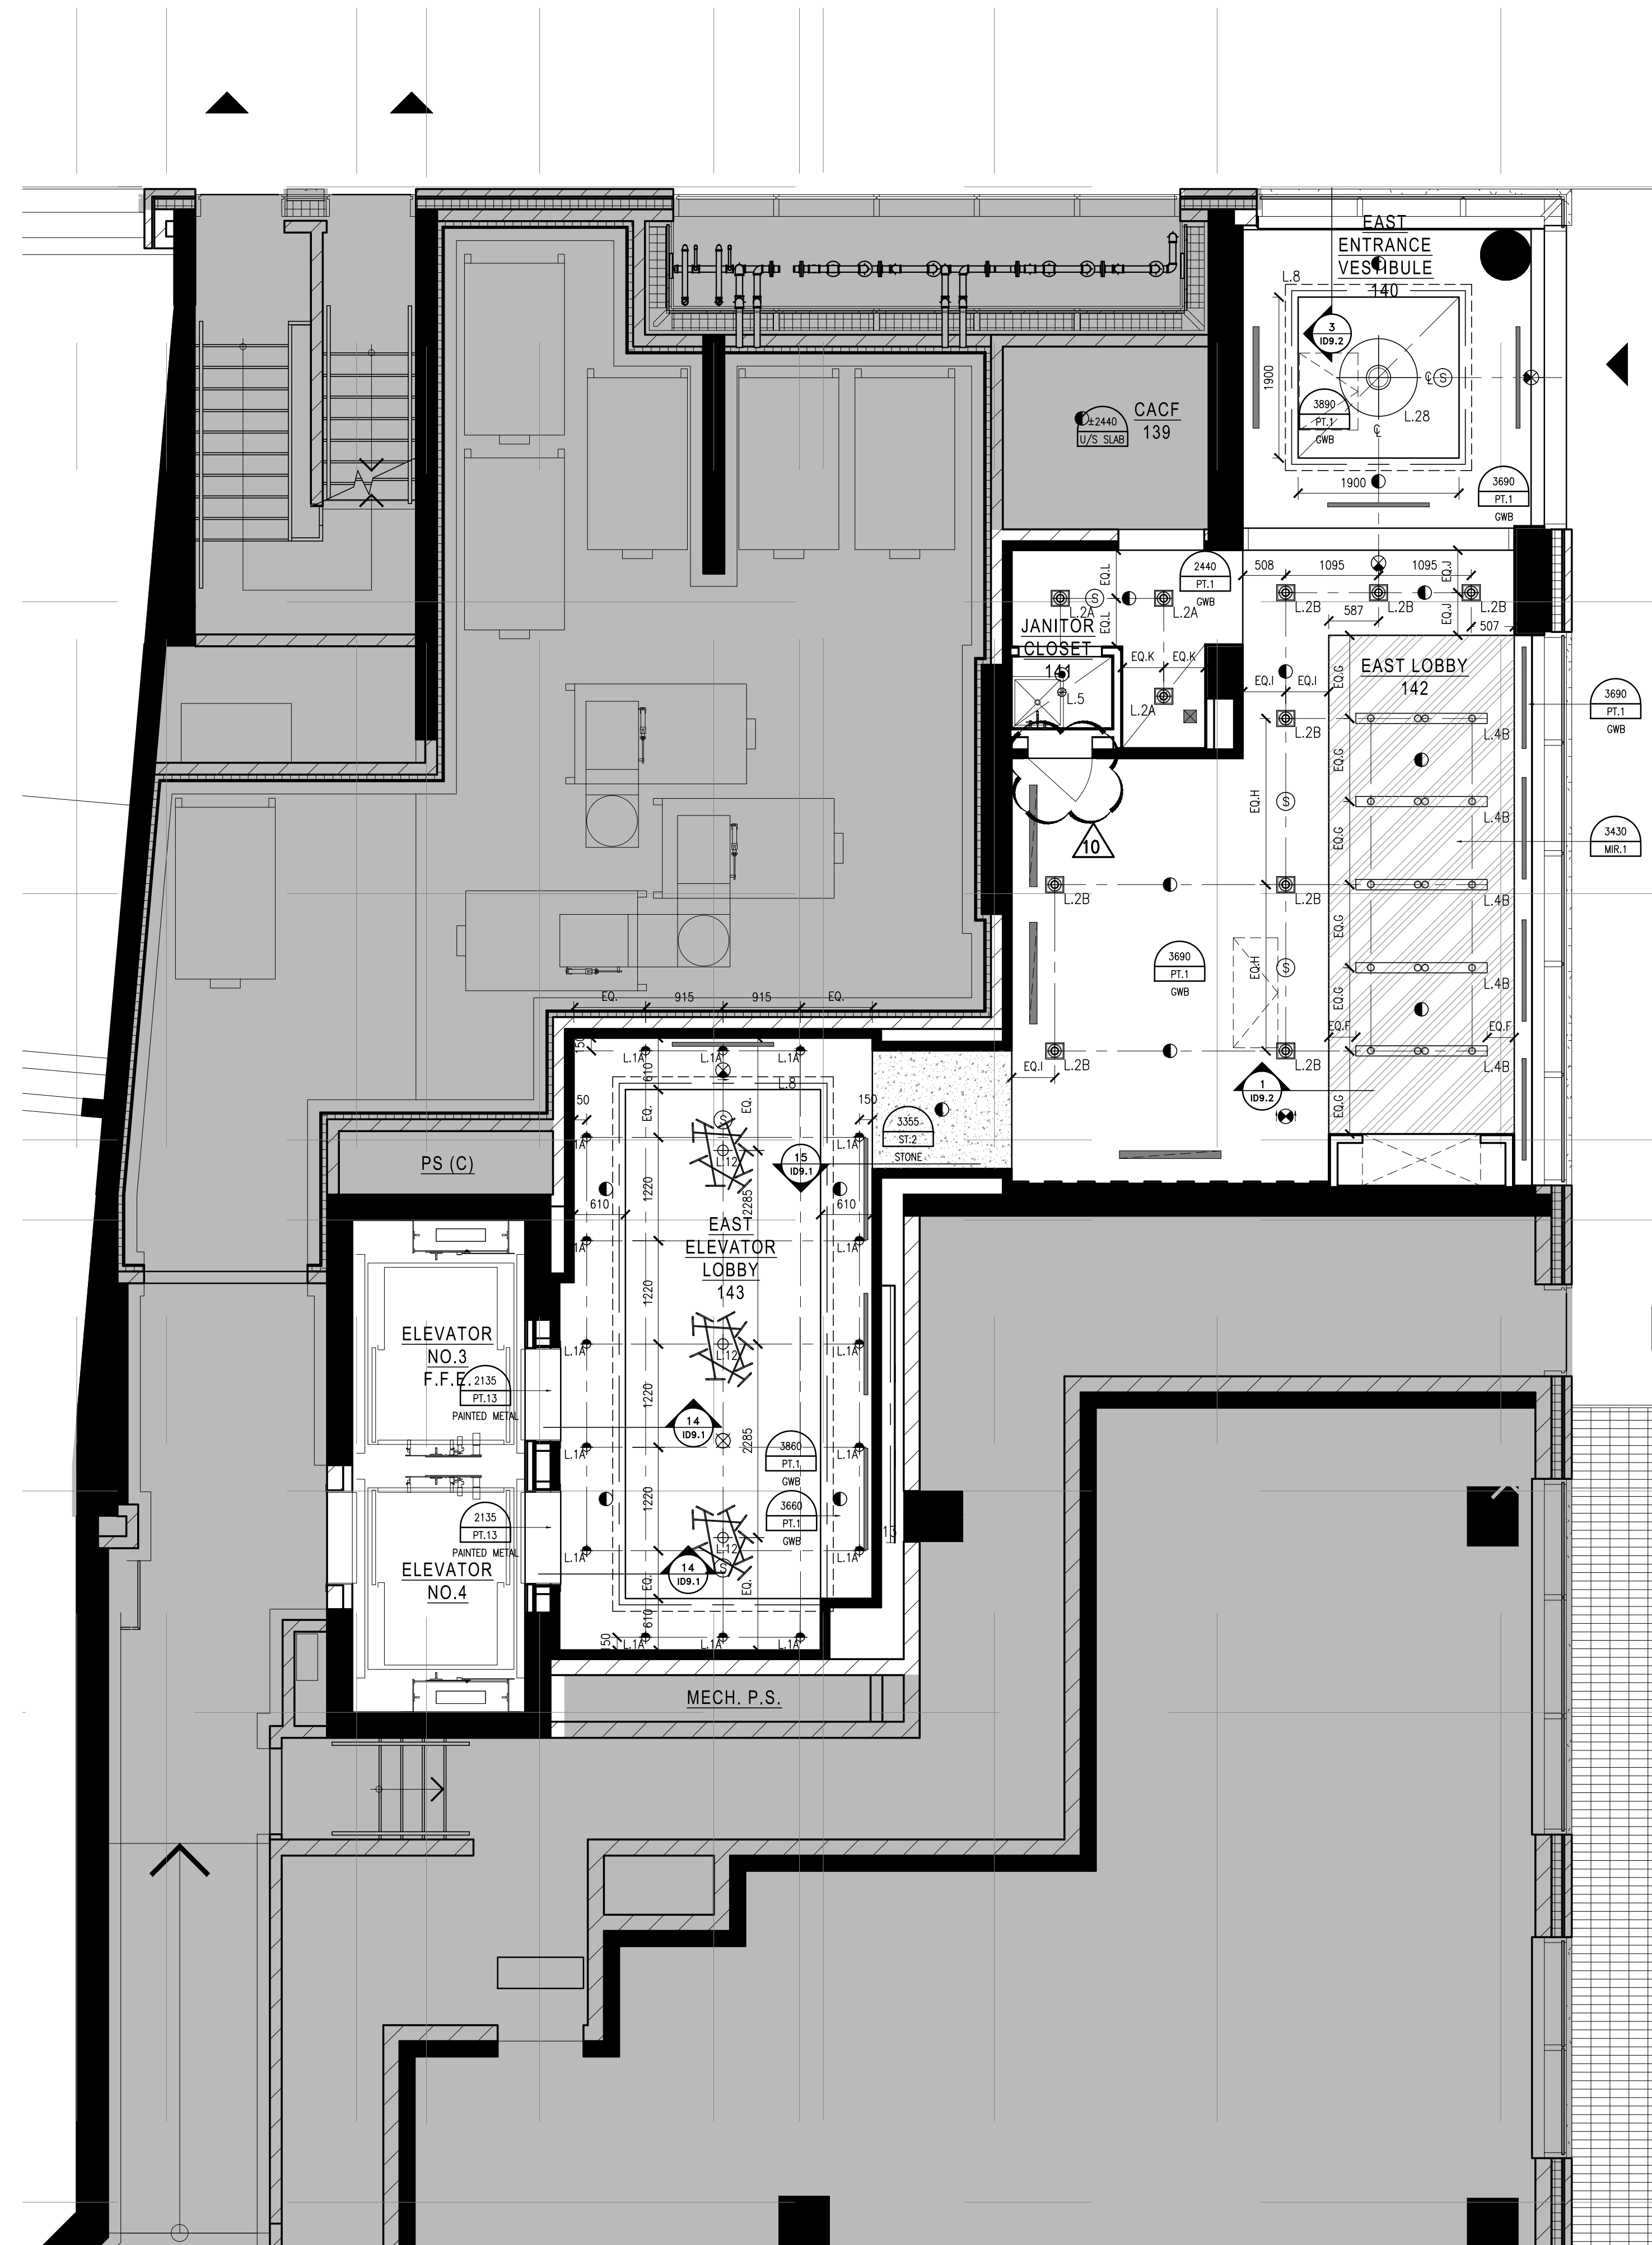

2 REFLECTED CEILING PLAN
ID3.6 SCALE 1:50

Hines TRIDEL®

1 EDGEWATER DRIVE, TORONTO ONTARIO

**II
BY
IV**
DESIGN

77 MOWAT AVENUE, SUITE 109
TORONTO, ONTARIO M5K 3E3 - CANADA
T + 1 416 531 2224

12 DESBROSSES STREET
NEW YORK, NEW YORK 10013 - USA
T + 1 212 392 4952

Drawing Title:
LEVEL 1
REFLECTED CEILING
PLAN

Our Project Number:	
14008	
Designed By:	Detailed By:
DM,KR, VW,SG	DM,KR, VW,SG,BP
Drawing Number:	

ID3.6